


ST ALOYSIUS SINGLE LINE DIAGRAM

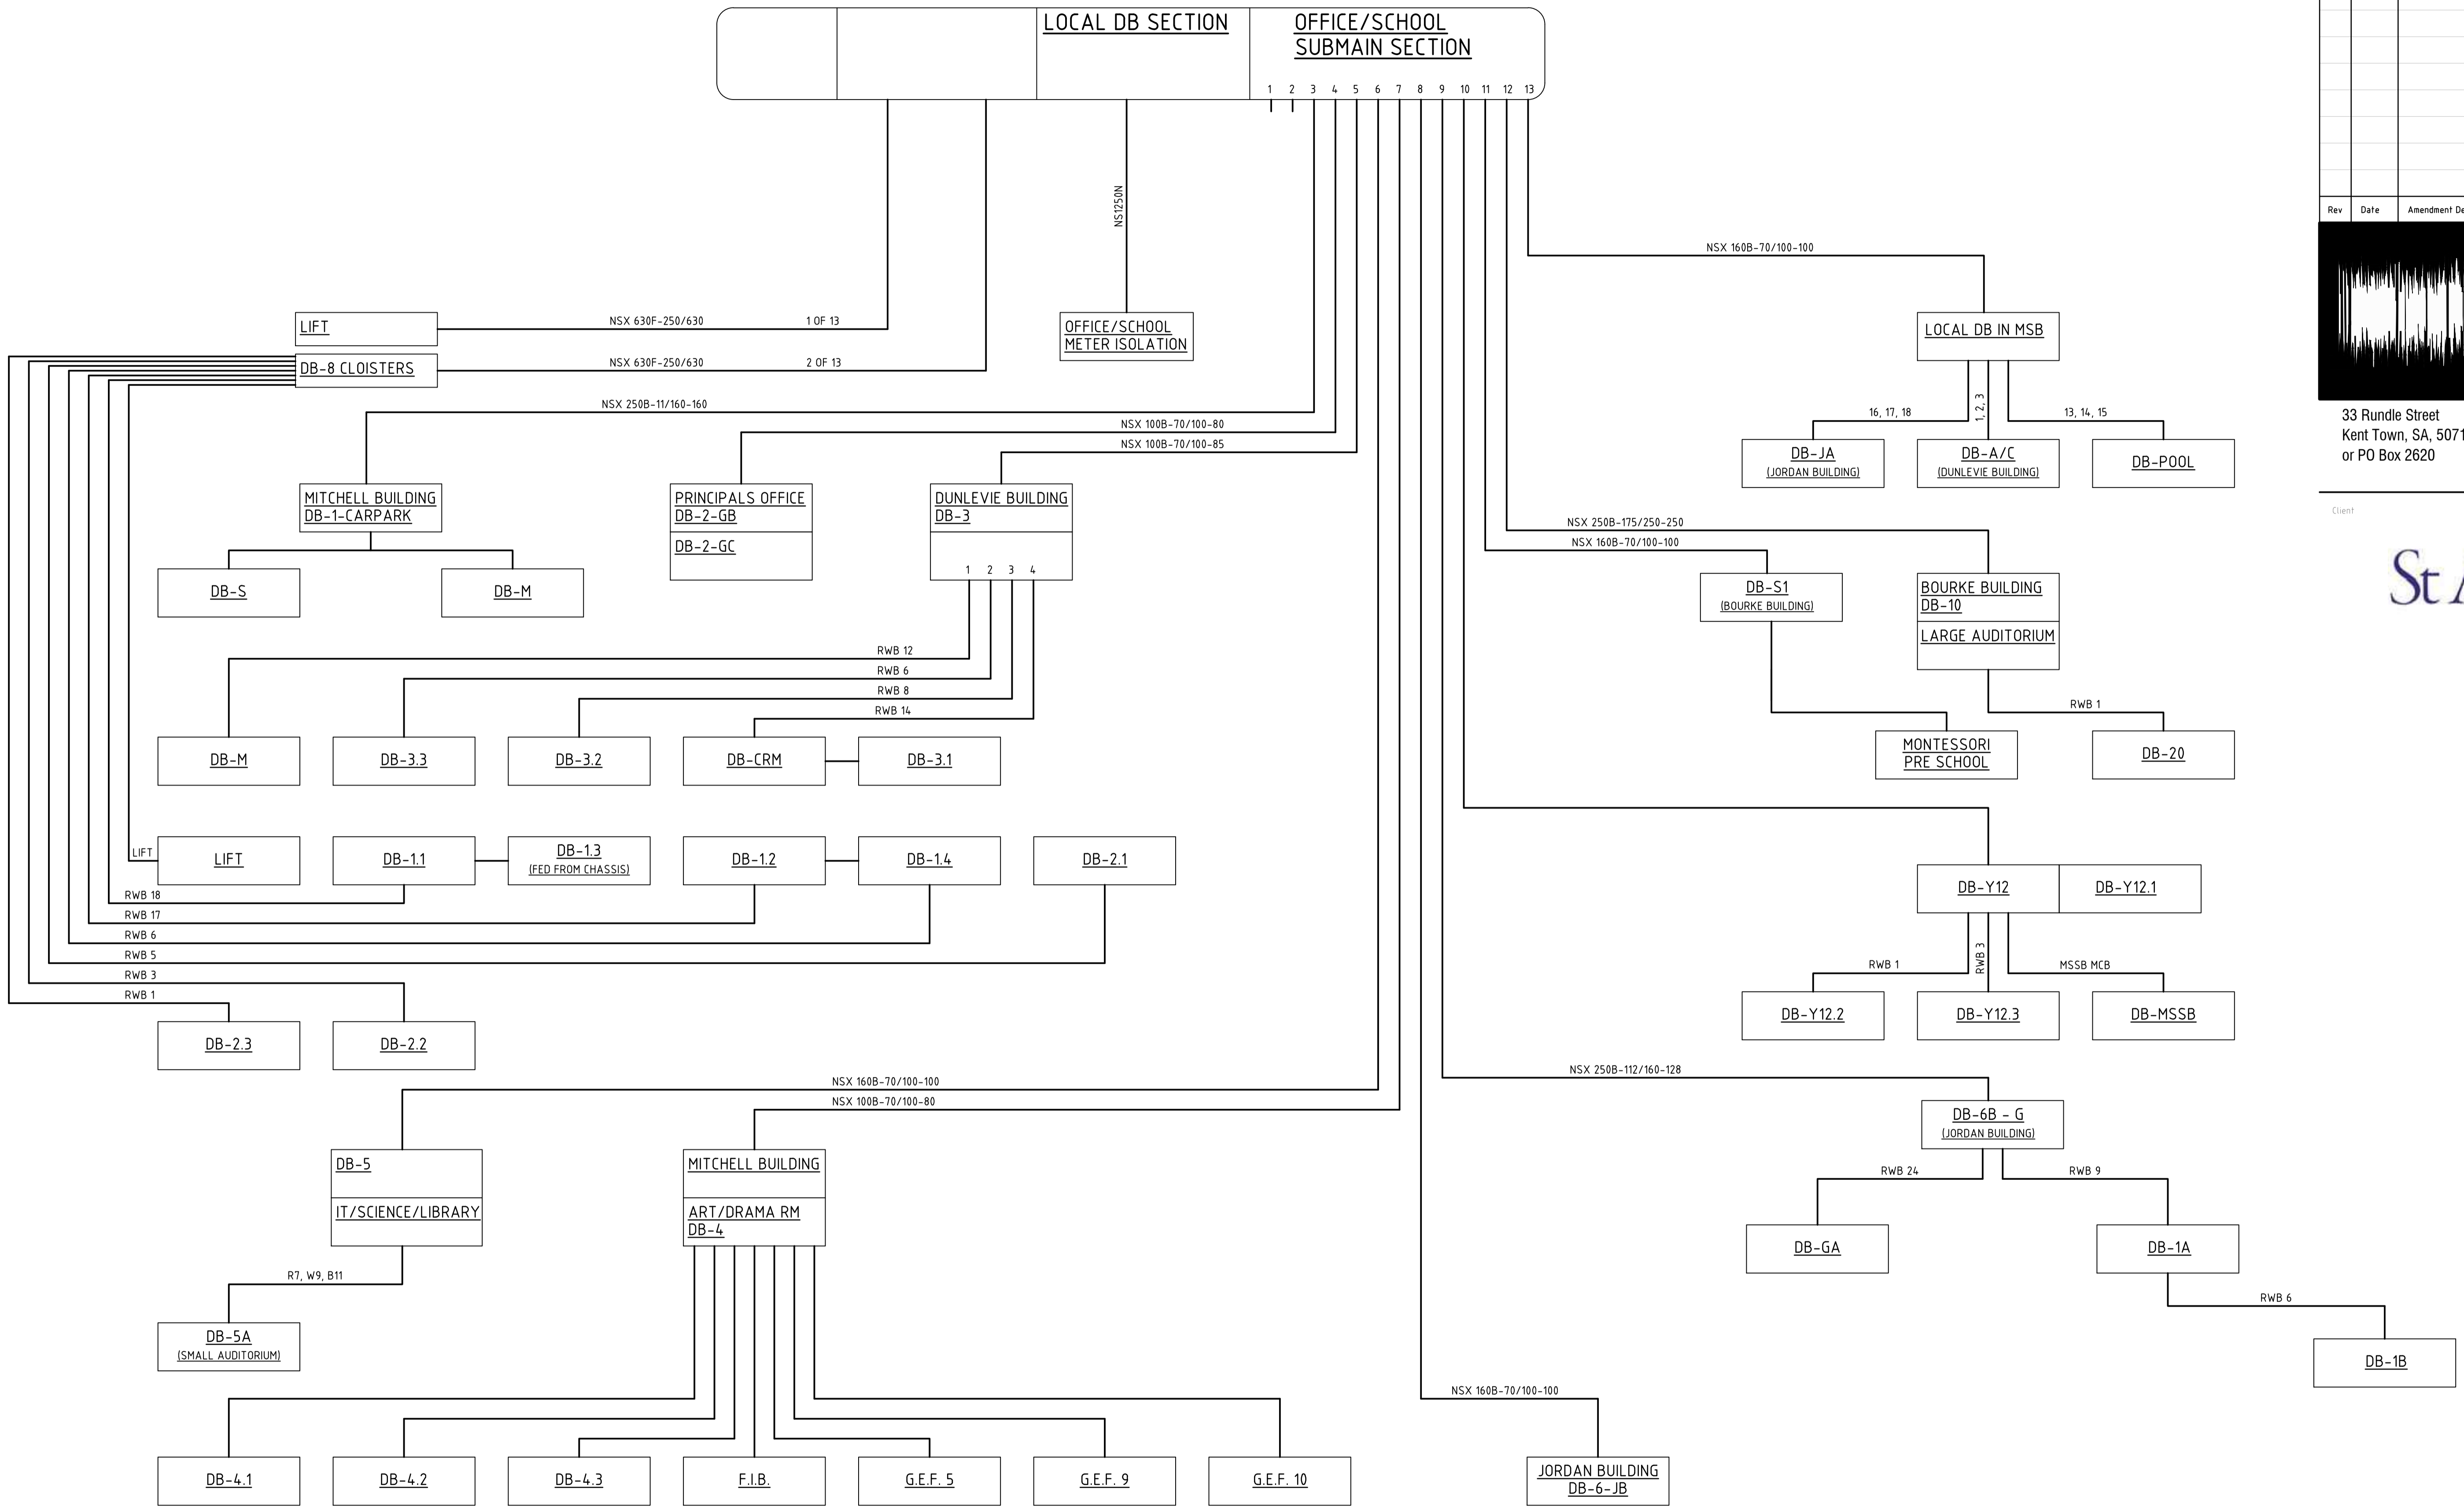

Rev	Date	Amendment Description	By	Chk

**bca**  
Engineers

33 Rundle Street  
Kent Town, SA, 5071  
or PO Box 2620

e. administration@bcaengineers.com  
p. 08 8132 1700



ELECTRICAL SERVICES FOR INFORMATION  
ELECTRICAL SINGLE LINE DIAGRAM

Drawing No. 0843-E00 Sheet 1 of 1	Revision 1	Scale @ A1 N.T.S. Date FEB 2014	Drawn MAM Approved PCC
---	---------------	--	---------------------------------

100mm AT FULL SIZE

© Copyright  
Use figured dimensions in preference to scaled. All dimensions to be verified and checked on the job.  
Any discrepancies in relation to scales to be brought to BCA's attention during Tender period.  
This Drawing is to be used as a guide for the preparation of Construction shop drawings.